



758 WESTBROOK STREET  
SOUTH PORTLAND, ME 04106  
(207)-221-6342

CLIENT:

TOWN OF WINDHAM

PROJECT ADDRESS

1 ENTERPRISE DRIVE  
WINDHAM ME

SYSTEM TYPE

BALLASTED GROUND  
MOUNT PHOTOVOLTAIC  
ARRAY

NOT FOR CONSTRUCTION

[illegible]

DESIGNED BY: SFC

PRINT SIZE: 24" x 36"

SCALE: 1" = 80'

DATE: JANUARY 16, 2020  
DWG TITLE:

SITE PLAN


TWO NUMBER:

A100

---

© COPYRIGHT REVISION ENERGY

THIS DIAGRAM IS PROVIDED AS A SERVICE AND IS BASED ON THE UNDERSTANDING OF THE INFORMATION SUPPLIED. IT IS SUBJECT TO CHANGE BASED ON ACTUAL CONDITIONS APPLICABLE EDITION OF THE NATIONAL ELECTRIC CODE, AND LOCAL GOVERNMENTAL AUTHORITIES.

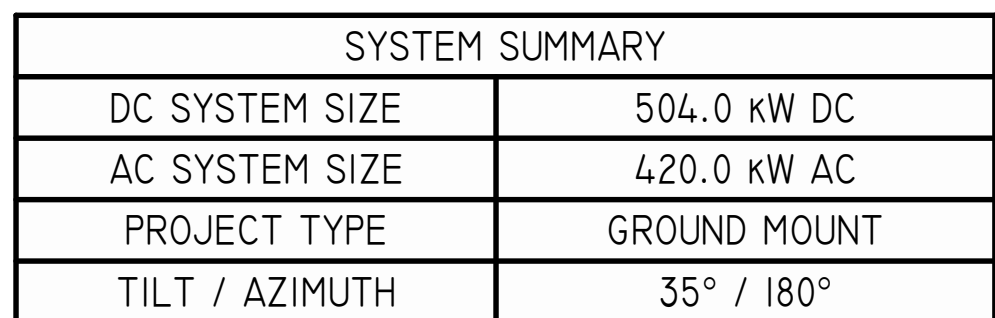

EQUIPMENT SUMMARY		
ITEM	DESCRIPTION	QTY
MODULE	REC 375TP2S 72 XV (375W)	1344
INVERTER	CPS SCA60KTL-DO/US-480	7
DAS	LOCUS L-GATE 360	1